



PRODUCED BY AN AUTODESK EDUCATIONAL PRODUCT

PRODUCED BY AN AUTODESK EDUCATIONAL PRODUCT

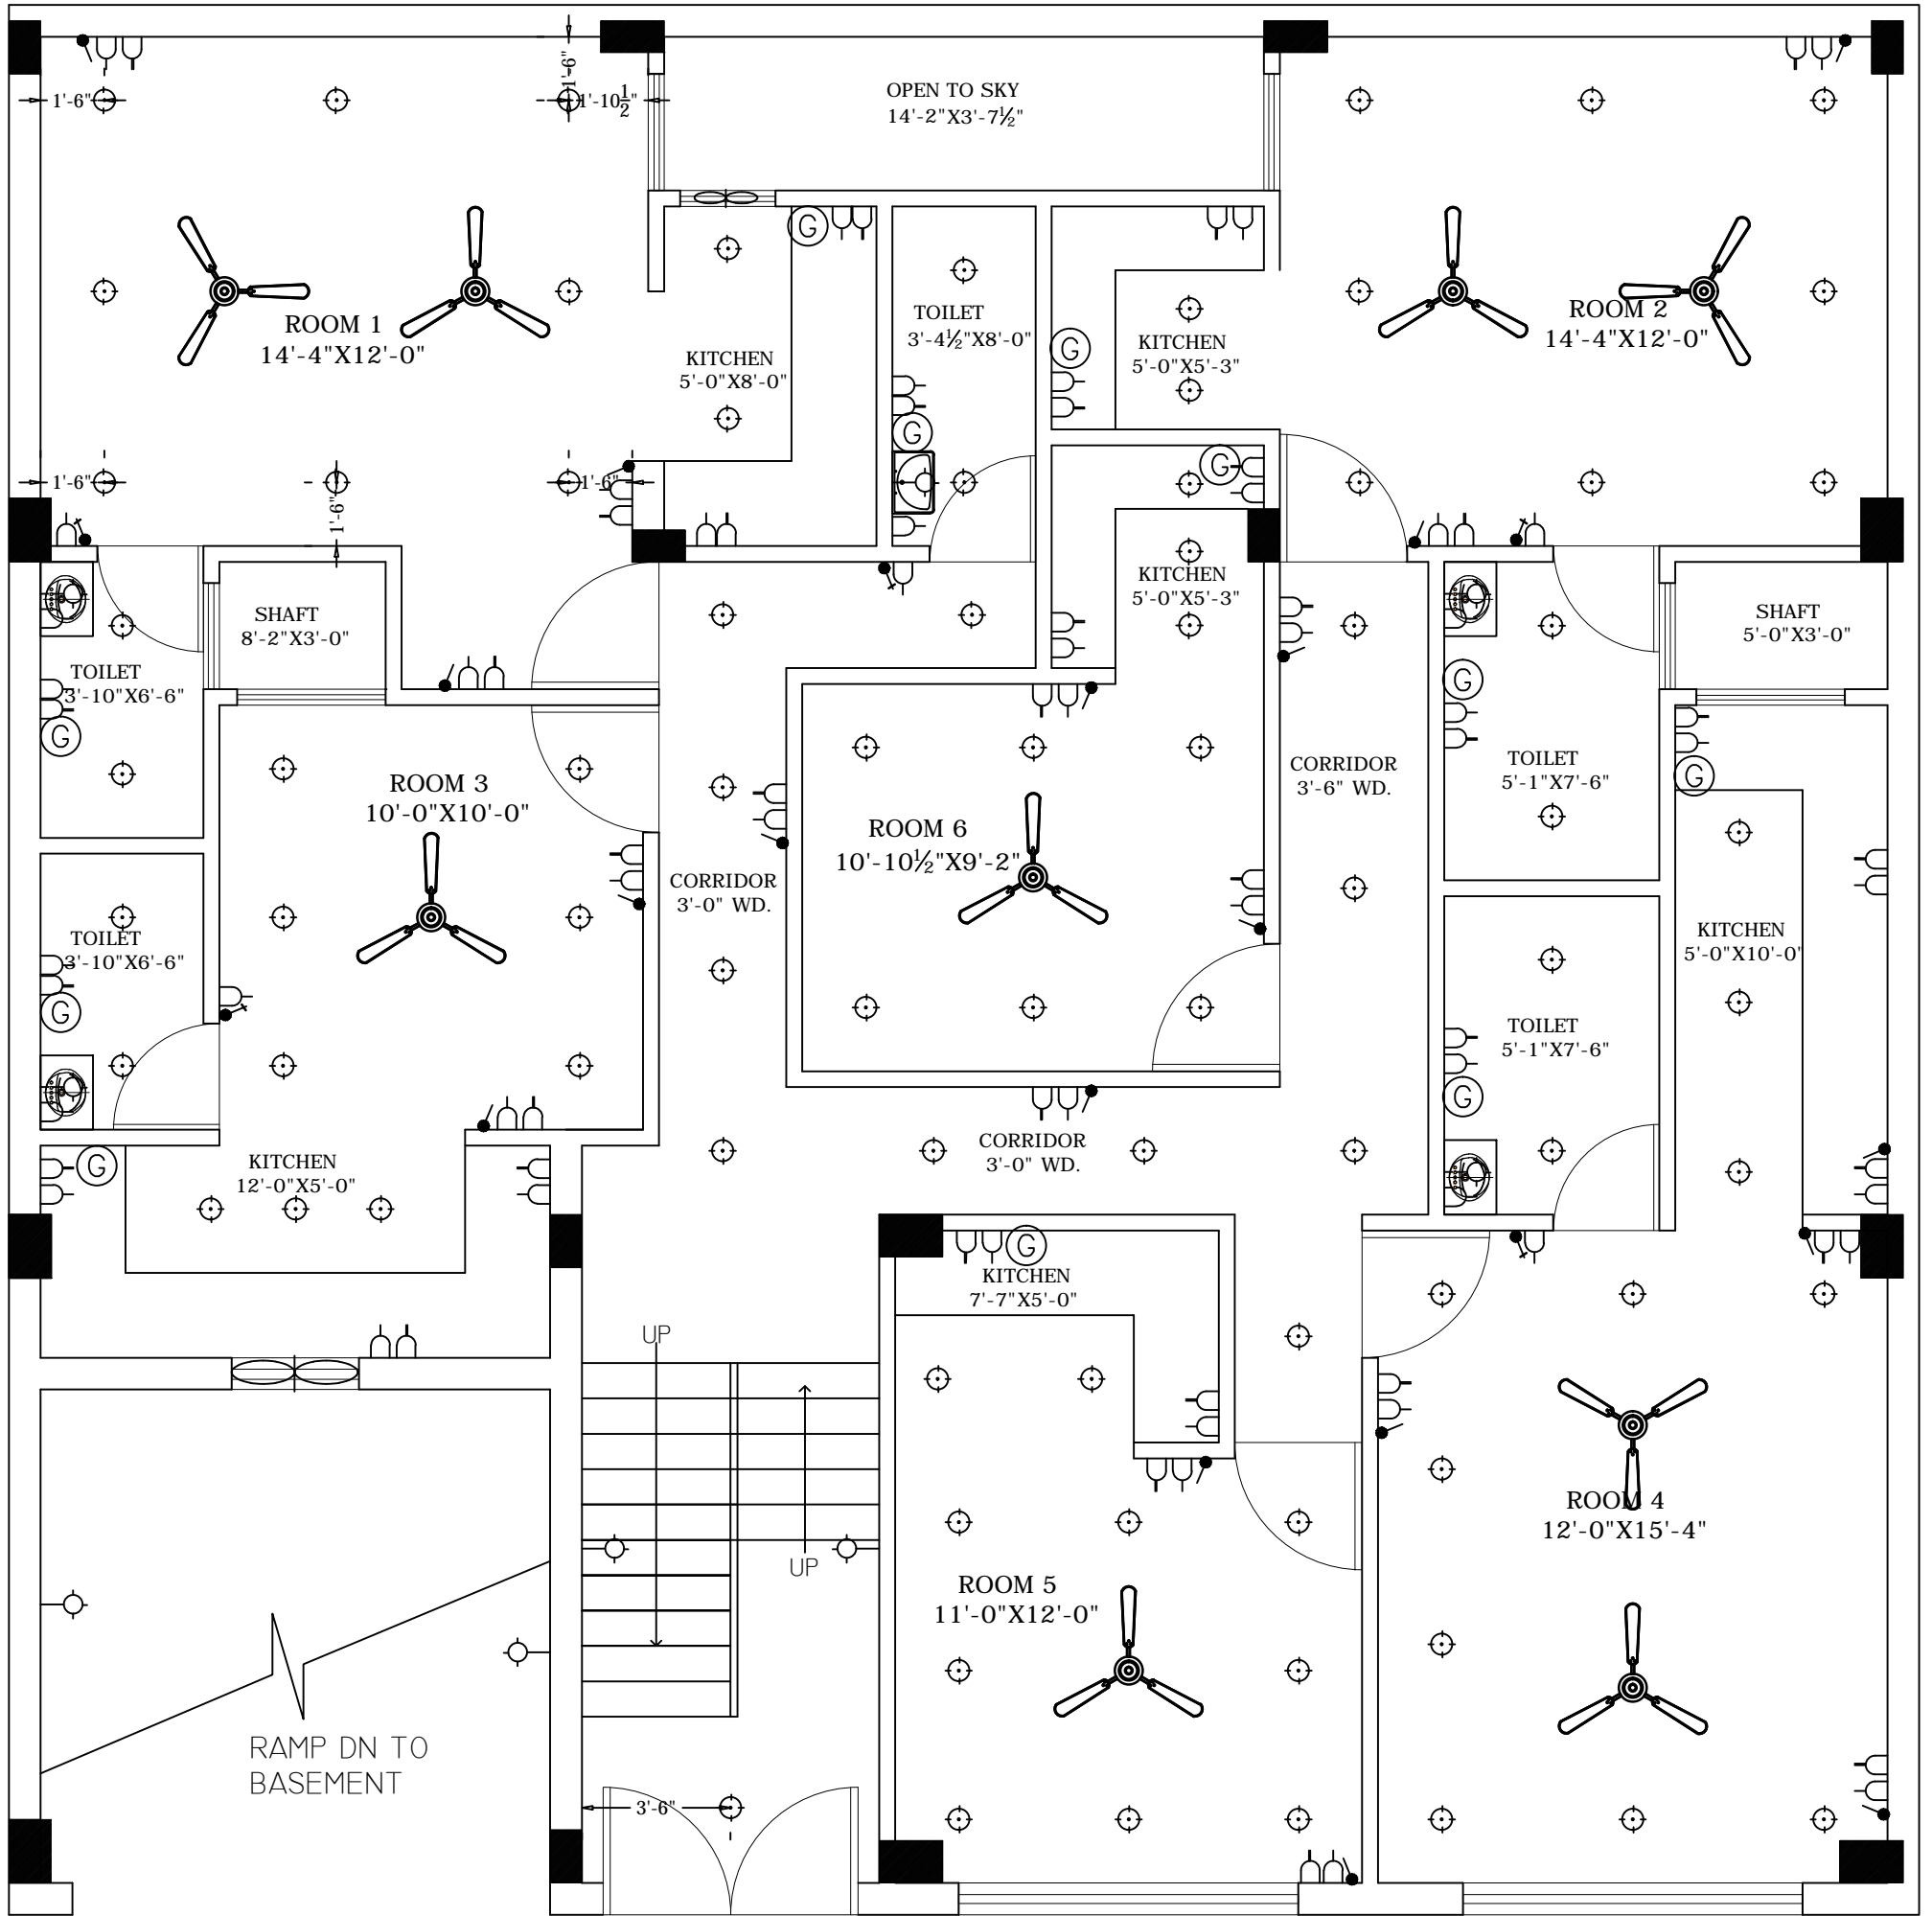

FRONT ROAD

**ELECTRICAL LAYOUT WORKING PLAN**

DRAWING TITLE:- <b>WORKING DRAWING</b> <u>LAYOUT</u>	PROJECT TITLE:- PROPOSED BUILDING DESIGN FOR MR.PITAMBAS DAAS ON PLOT NO. .... GURUGRAM, HARYANA	SCALE	ARCHITECTS:- <b>DESIGN BAY</b> ARCHITECTS,ENGINEERS,INTERIOR DESIGNERS Mobile :-9873013251, 8505929651,011-28521294 E-MAIL:- vkar.vinitkumar01@gmail.com E-MAIL:- designbay2007@gmail.com	DATE: 12-07-2018
		DRAWING NO. 1		
		DEALT BY:		
		CHKD. BY: AR.VINIT KUMAR		